

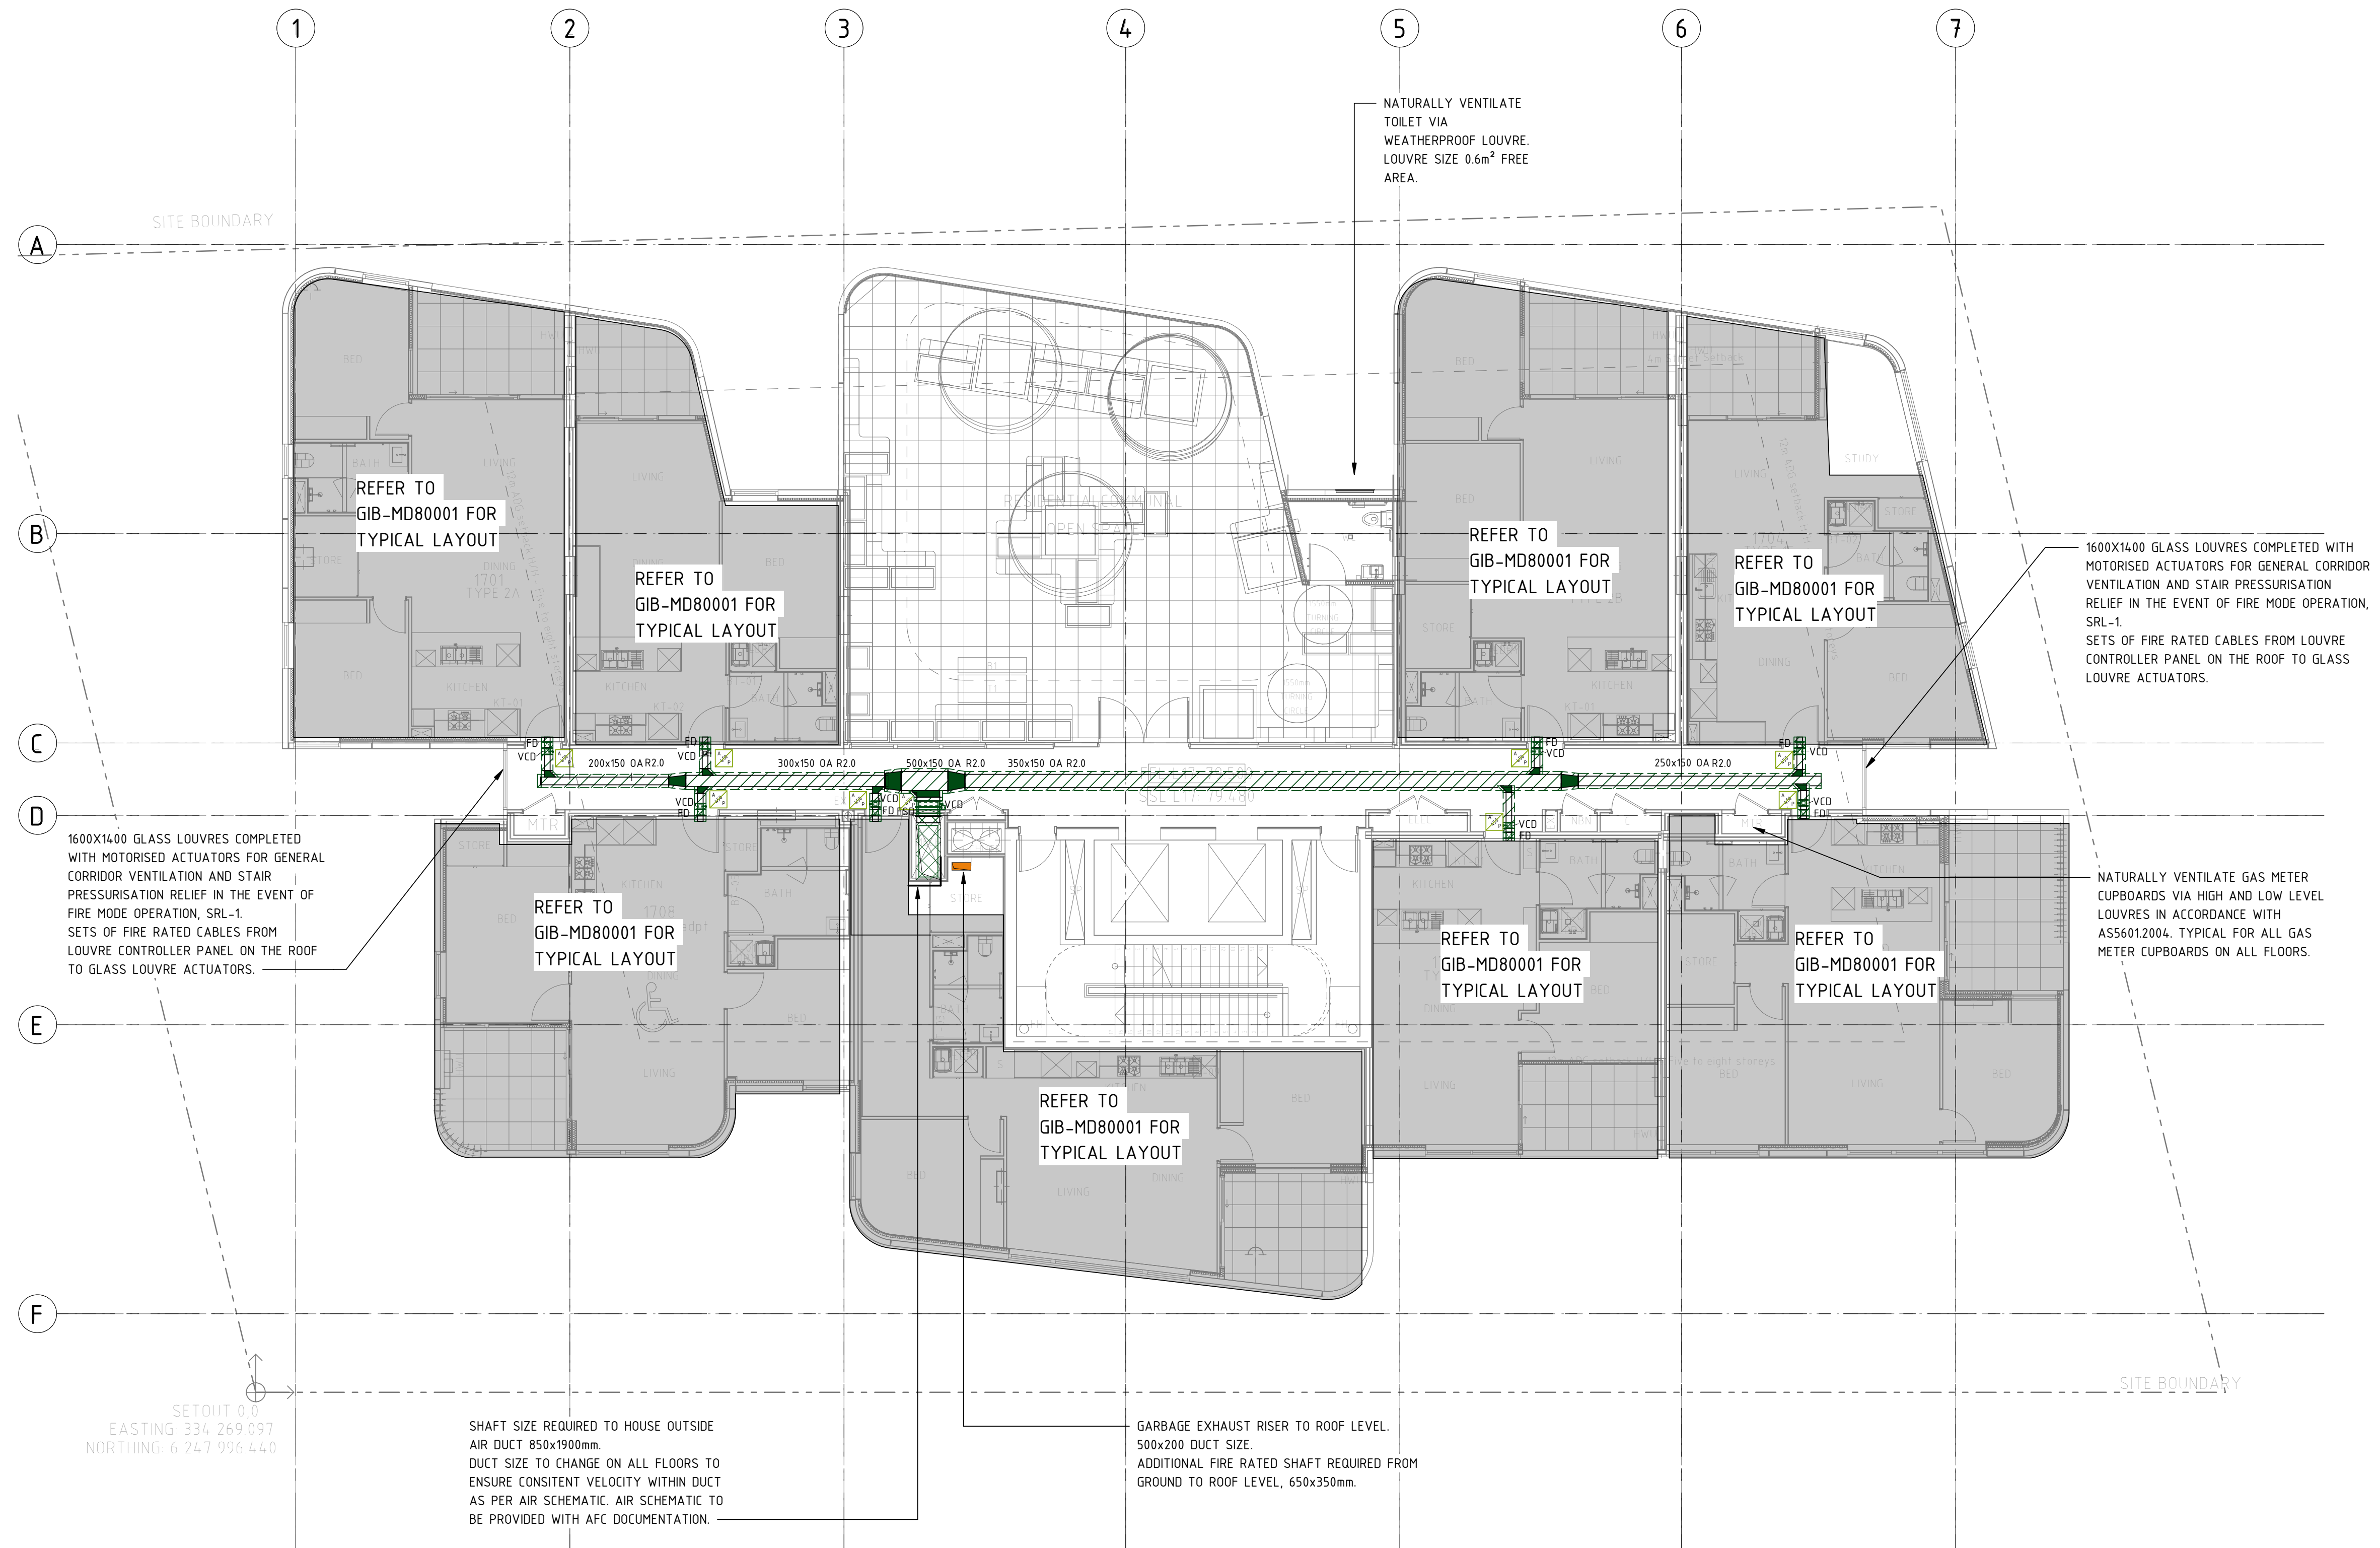
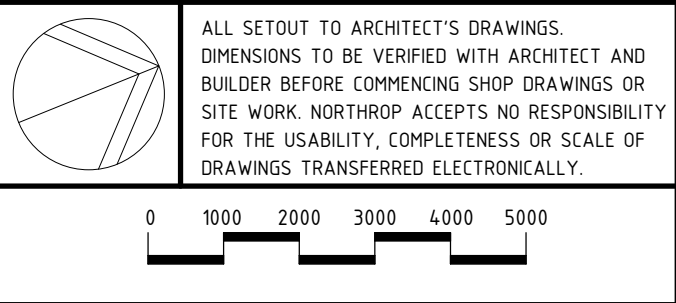


VERIFIER: DCIANCI
JOB MANAGER: GHARRIS
DESIGNED: GHARRIS
DRAWN: A.VLAHOIOTIS

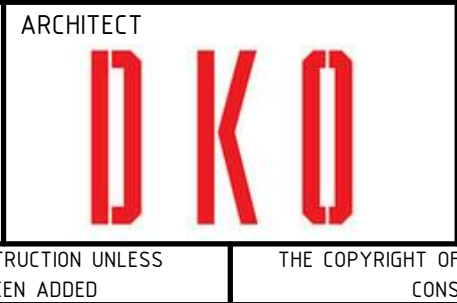

NOT FOR CONSTRUCTION

REV	DESCRIPTION	ISSUED	VERD	APP'D	DATE
1	ISSUE FOR PRICING	A.V		P.Y	16.04.19
2	ISSUE FOR PRICING	A.V		P.Y	03.05.19
3	ISSUE FOR PRICING	A.V		P.Y	07.05.19
4	REVISED ISSUE FOR PRICING	G.H		G.H	28.05.19
A	D&C TENDER	P.B		G.H	21.06.19

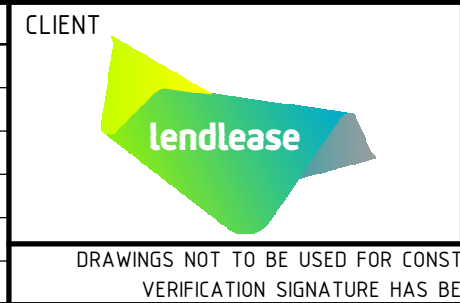

PROJECT
11 GIBBONS STREET REDFERN, NSW 2016

DRAWING TITLE
MECHANICAL SERVICES LEVEL 17 HVAC LAYOUT

JOB NUMBER
SY183106
DRAWING NUMBER
GIB-MD31700
REVISION
A
DRAWING SHEET SIZE ≥ A1